



This drawing with all its contents is the sole intellectual property of the NIRT, CHENNAI. Copying or part thereof or its use in any form whatsoever without the written permission is prohibited.

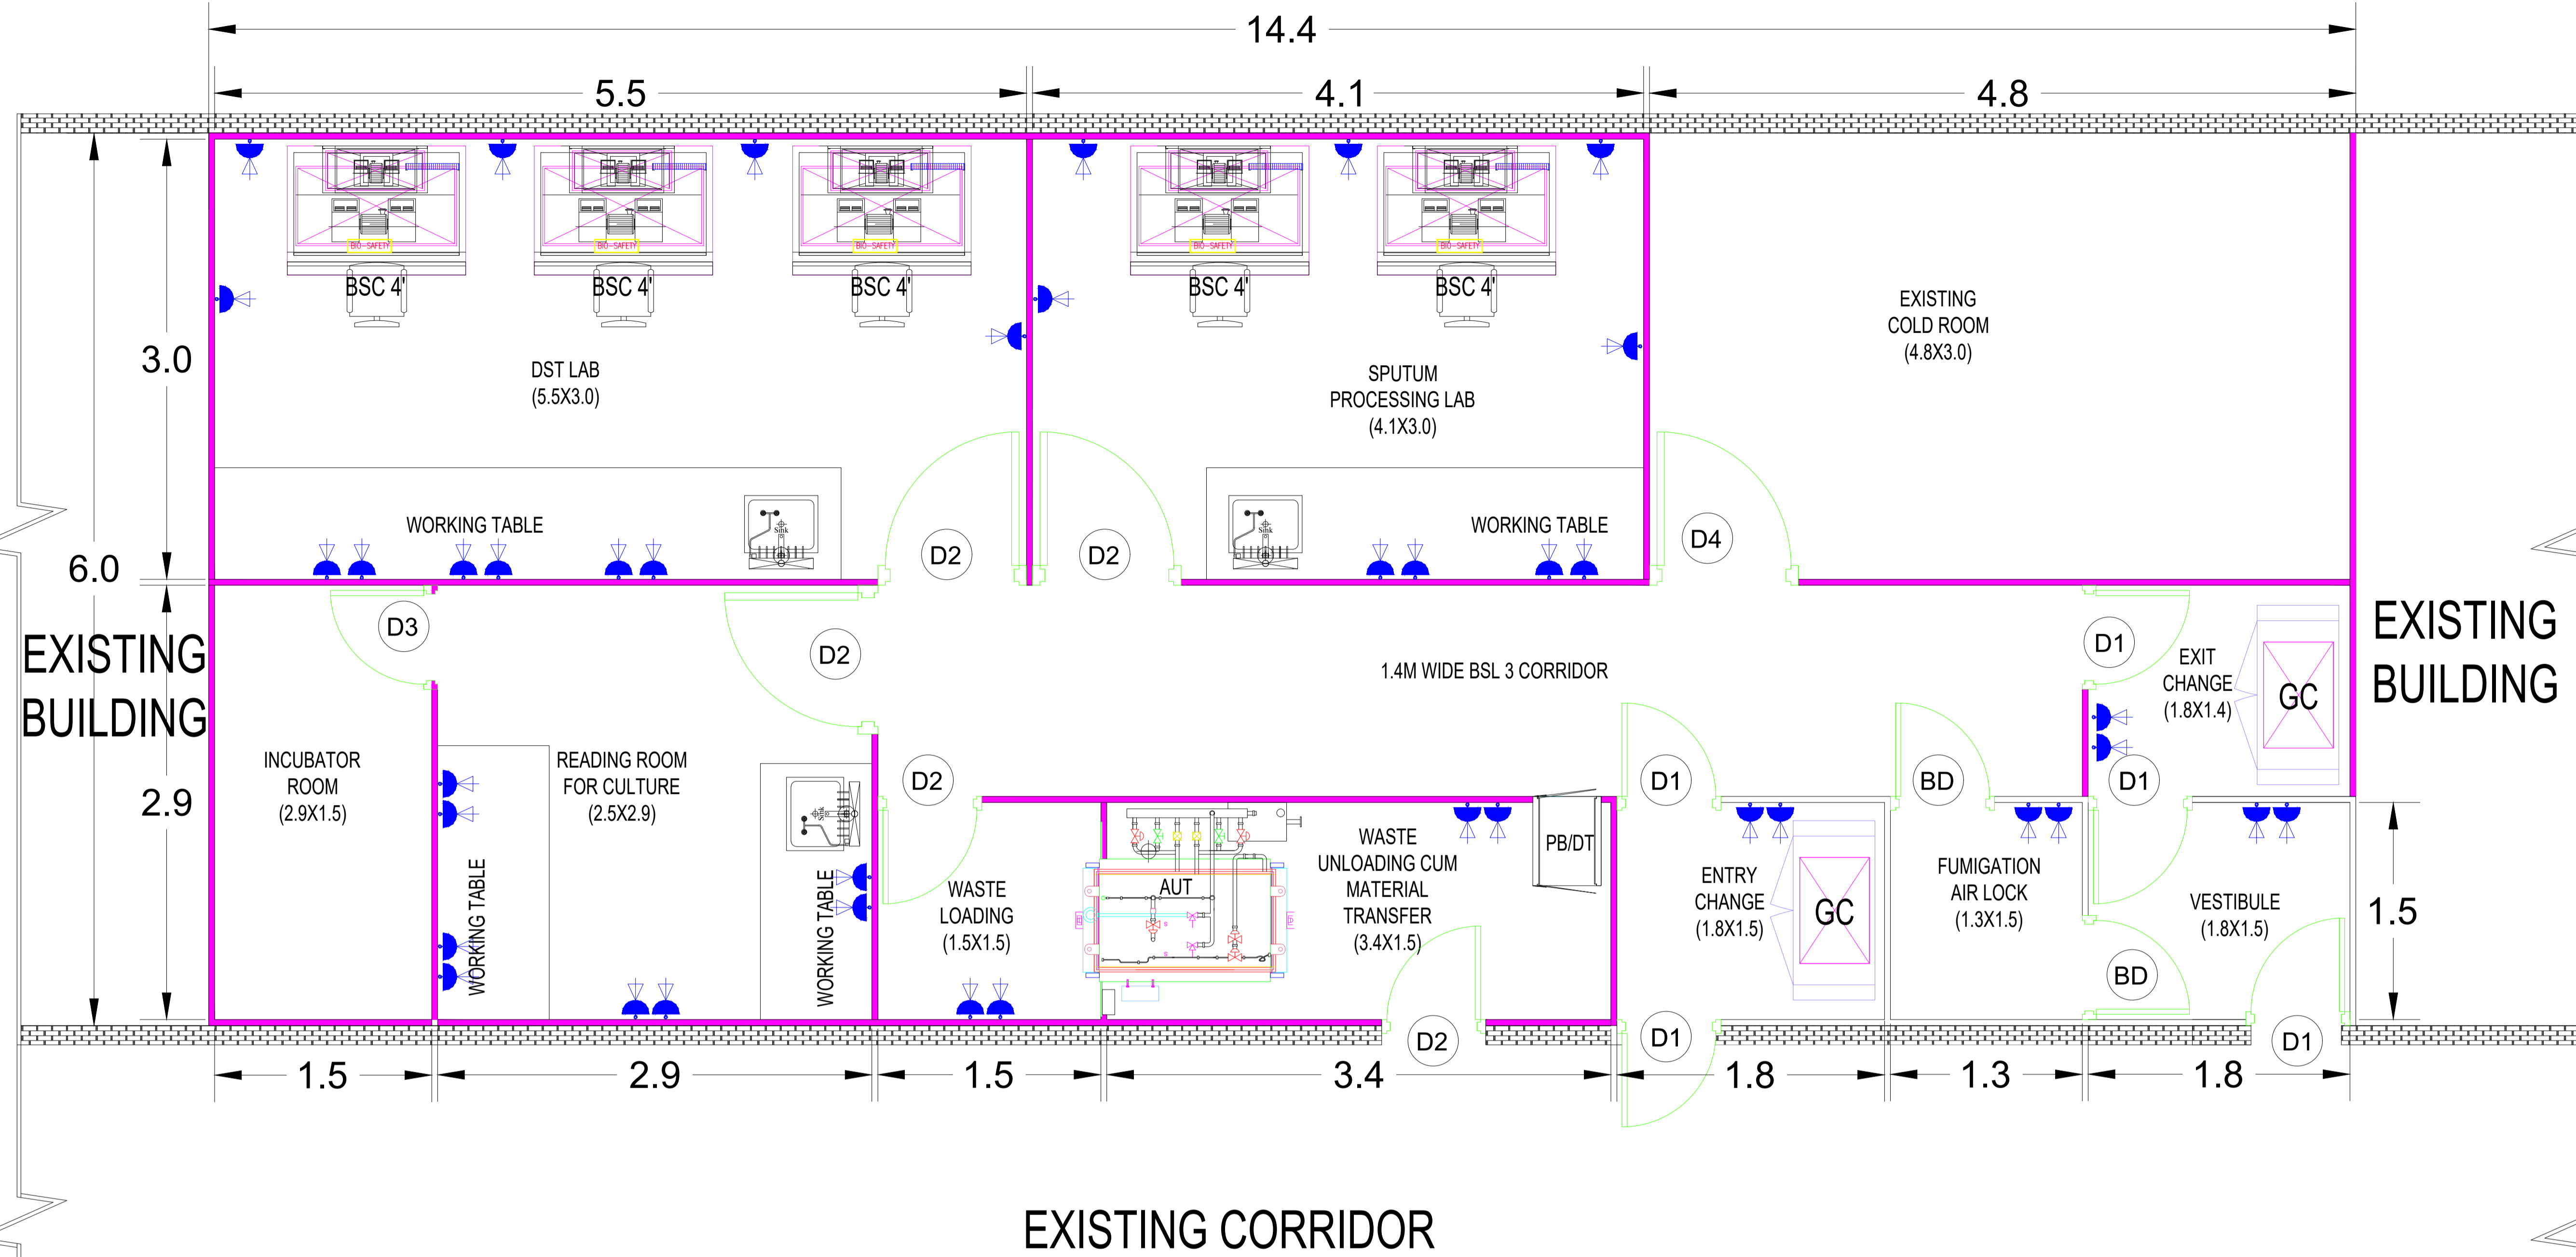


LEGEND:

| | |
|-------|---------------|
| (D1) | 1000X2100MM |
| (D2) | 1200X2100MM |
| (D3) | EXISTING DOOR |
| (D4) | EXISTING DOOR |
| (BD1) | 1200X2100MM |

 82MM PUF PANEL

 BIO SAFETY CABINET

 PASS BOX/DUNK TANK

 AUTOCLAVE

 GARMENT CABINET

PROJECT
SOLID CULTURE LABORATORY (BSL3) AT NIRT, CHENNAI

CLIENT:-
 NIRT CHENNAI

TITLE:-
 POWER LAYOUT

Drawing No.
 NIRT/DST/BSL3/01

| Scale | Date | REV. |
|-------|------------|------|
| | 27.12.2018 | R0 |

| LEGEND | DESCRIPTION |
|---|---------------------------------------|
|  | 16A SWITCH / SOCKET (IP-55 OR BETTER) |