


This drawing with all its contents is the sole intellectual property of the NIRT, CHENNAI. Copying or part thereof or its use in any form whatsoever without the written permission is prohibited.

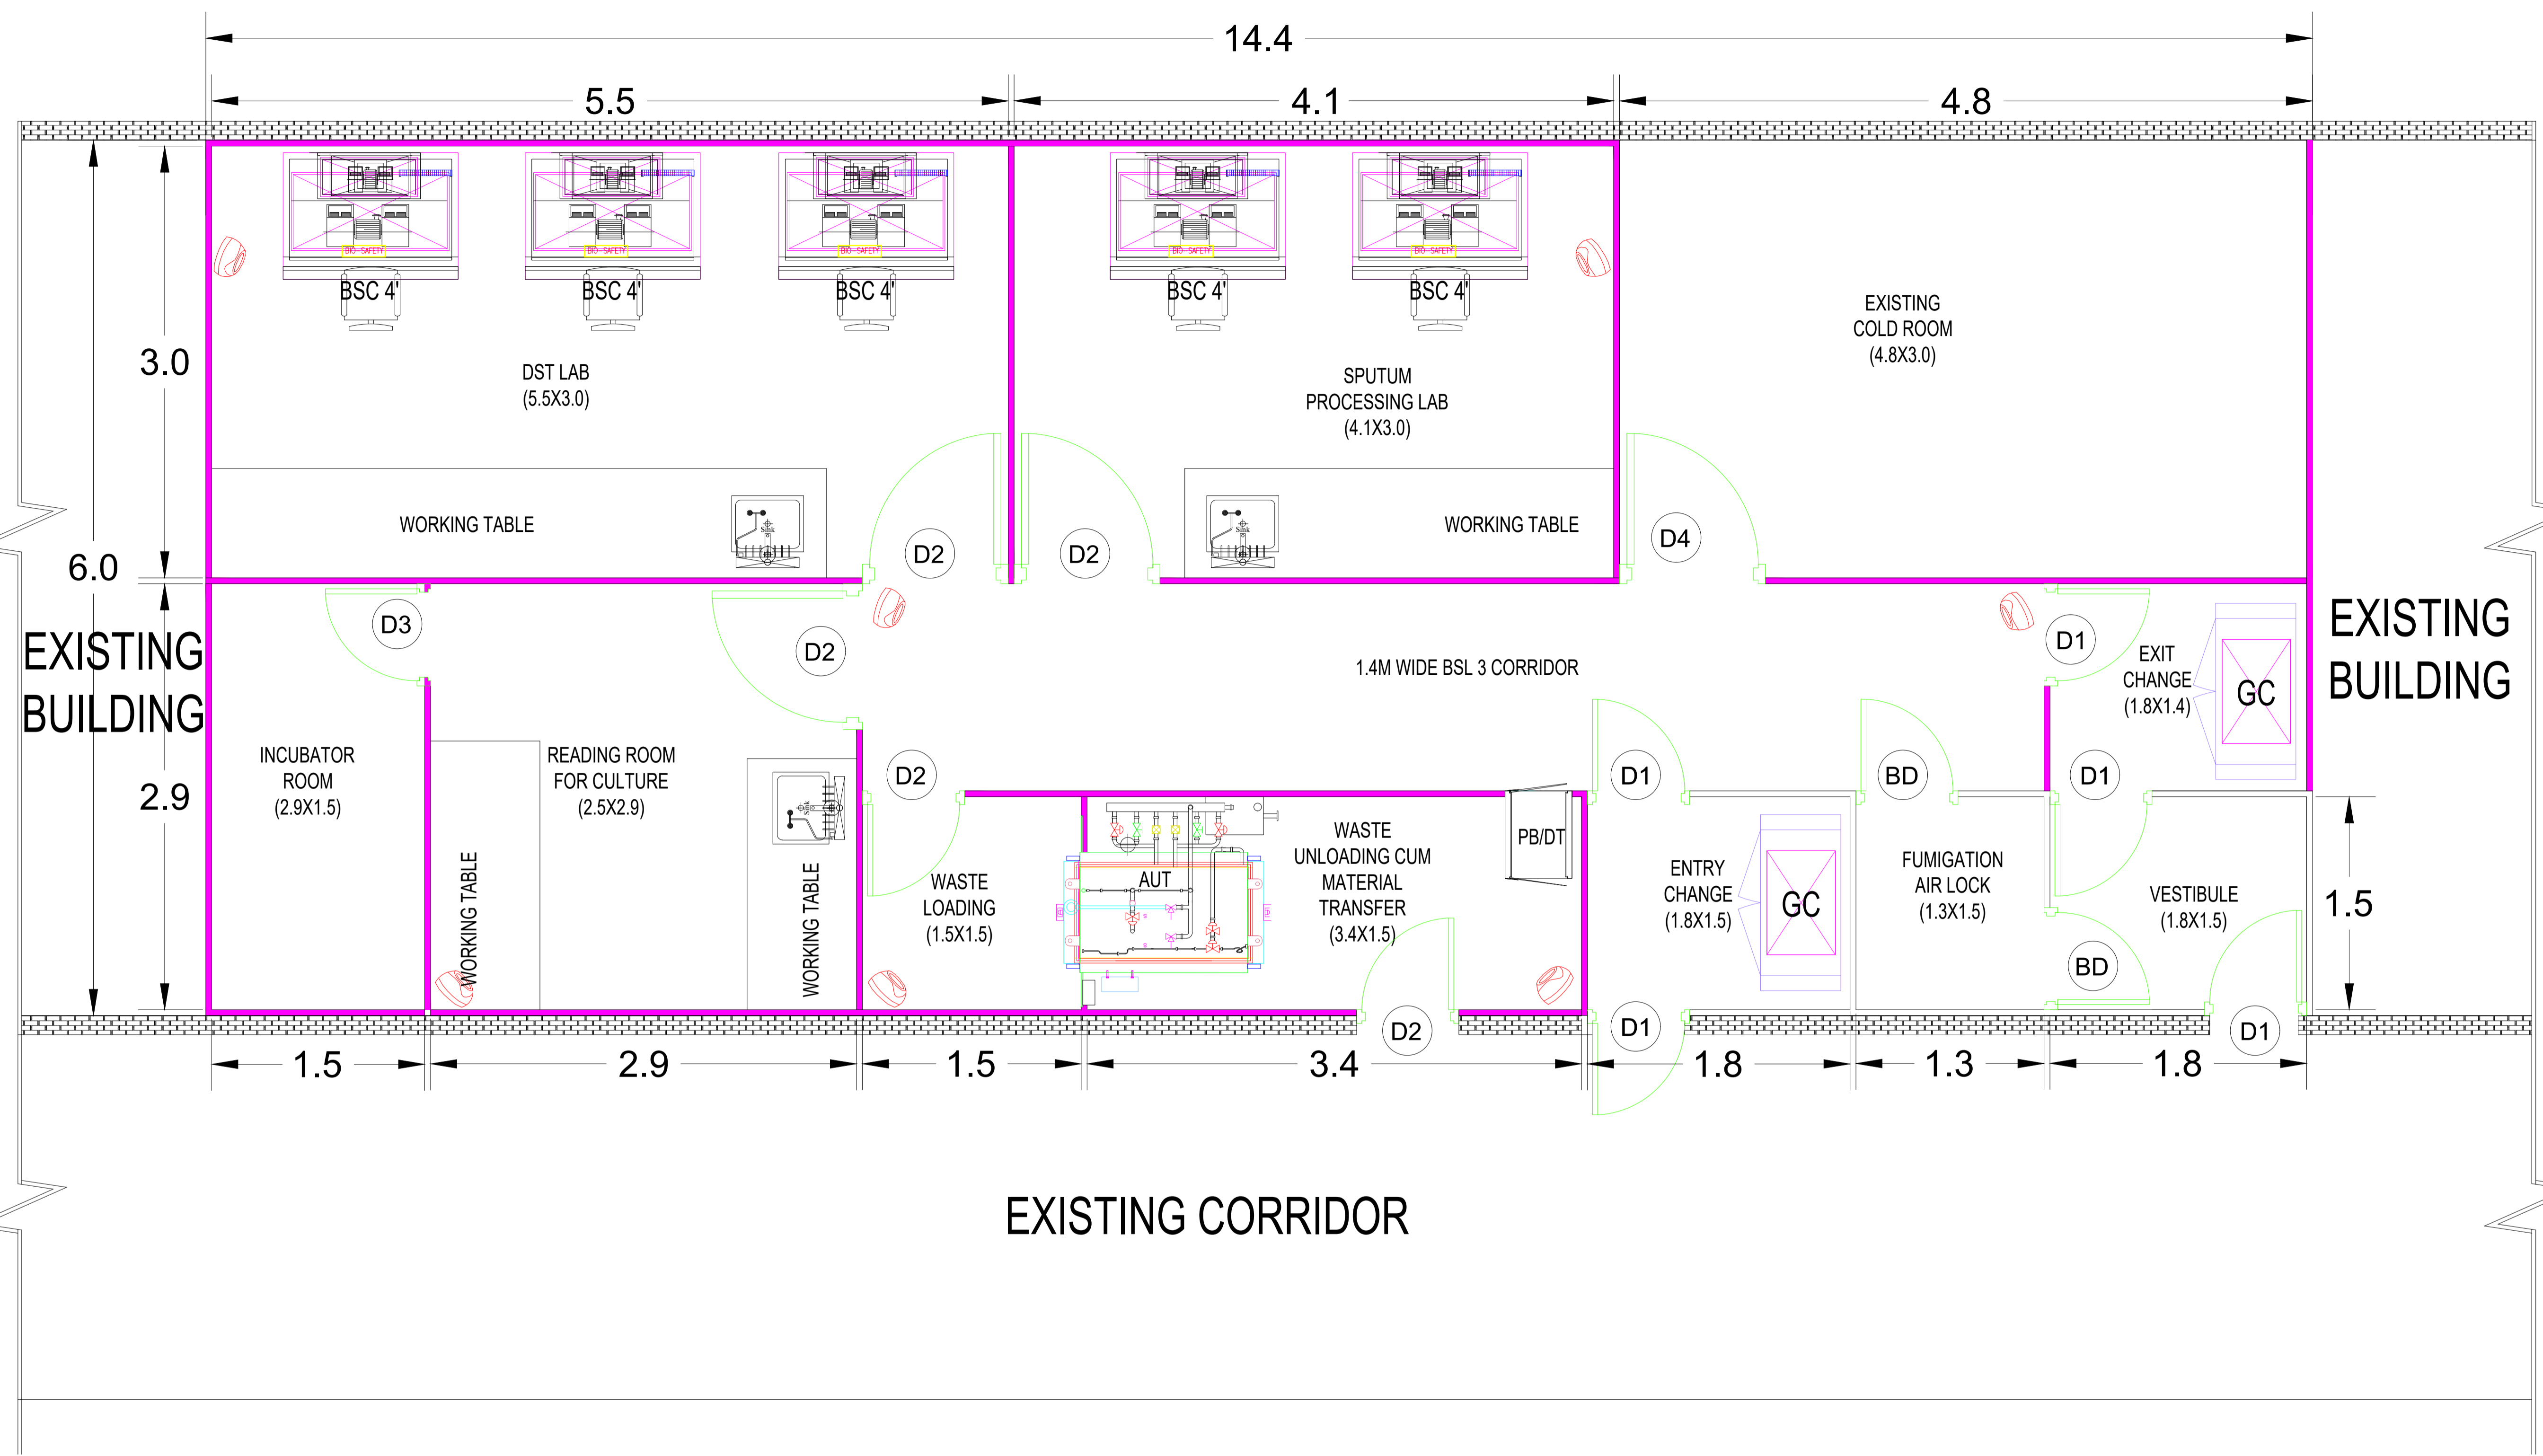

LEGEND:

(D1)	1000X2100MM
(D2)	1200X2100MM
(D3)	EXISTING DOOR
(D4)	EXISTING DOOR
(BD1)	1200X2100MM

	82MM PUF PANEL
	BIO SAFETY CABINET
	PASS BOX/DUNK TANK
	AUTOCLAVE
	GARMENT CABINET

PROJECT
SOLID CULTURE LABORATORY (BSL3) AT NIRT, CHENNAI

CLIENT:-
 NIRT CHENNAI

TITLE:-
 CCTV LAYOUT

Drawing No.
 NIRT/DST/BSL3/01

Scale	Date	REV.
	27.12.2018	R0

LEGEND	DESCRIPTION
	DOME CAMERA