


This drawing with all its contents is the sole intellectual property of the NIRT, CHENNAI. Copying of this drawing or part thereof or its use in any form whatsoever without the written permission is prohibited.

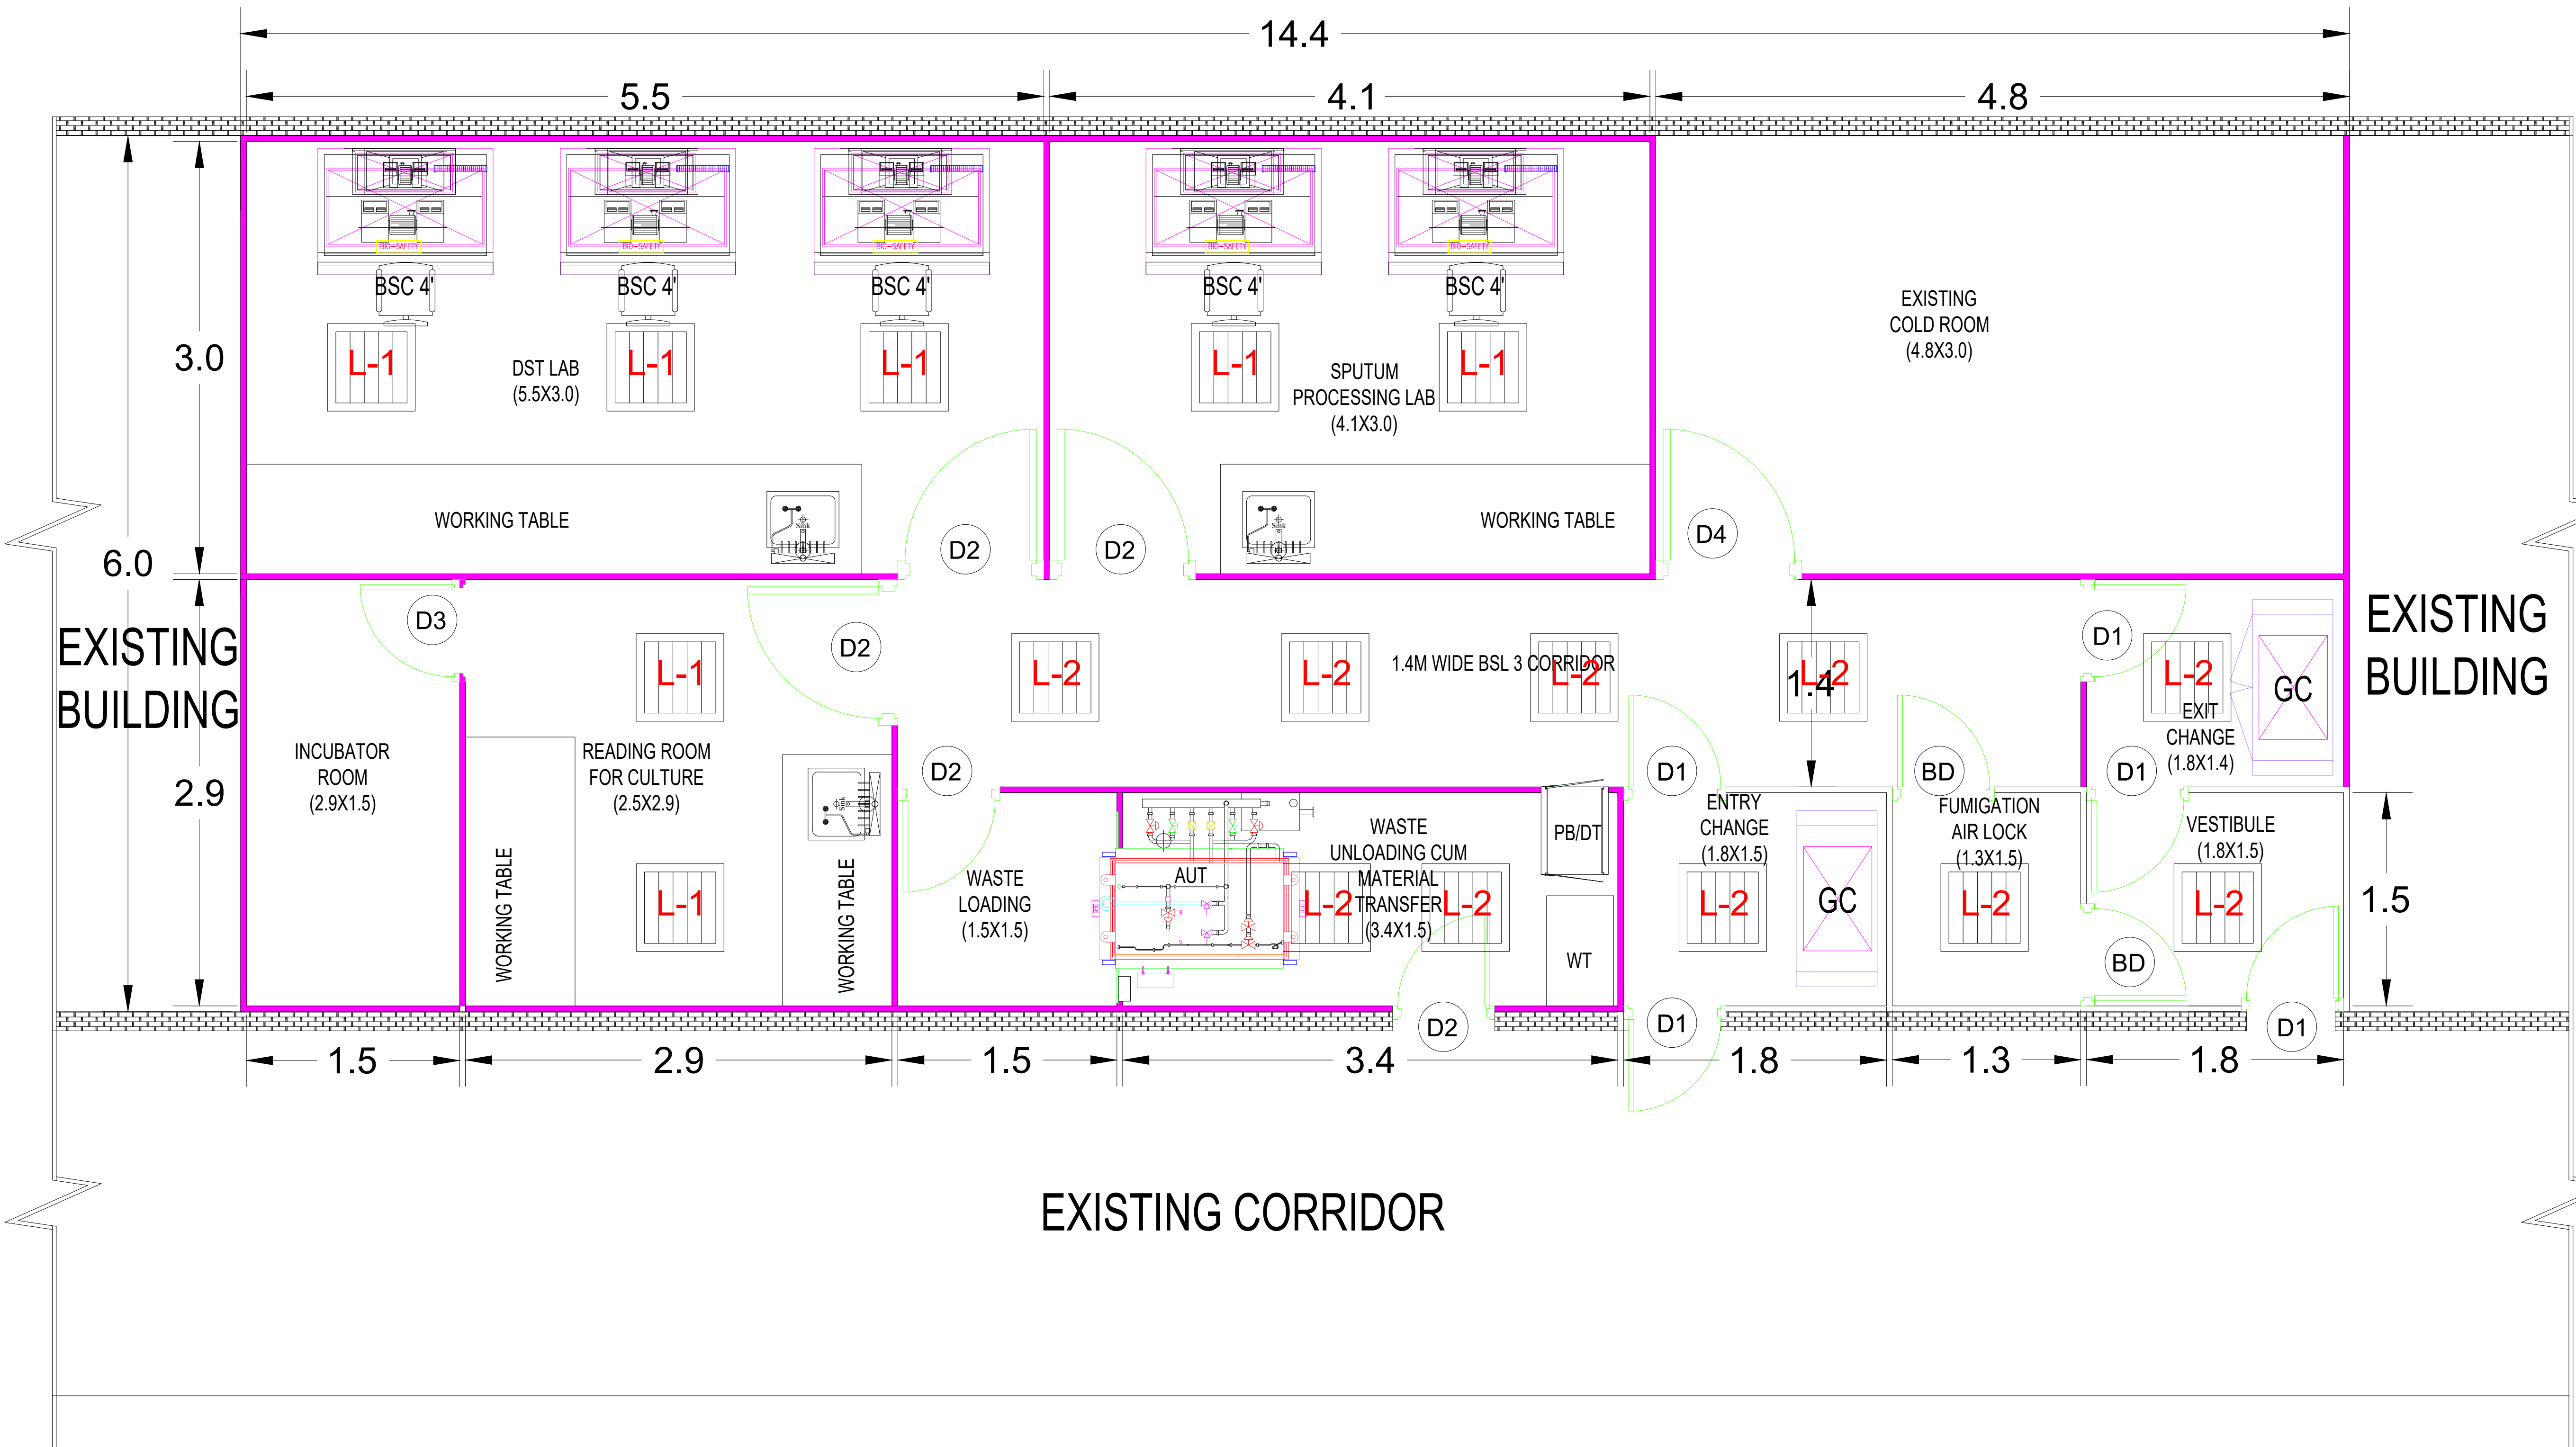

LEGEND:

(D1)	1000X2100MM
(D2)	1200X2100MM
(D3)	EXISTING DOOR
(D4)	EXISTING DOOR
(BD1)	1200X2100MM

82MM PUF PANEL

BIO SAFETY CABINET

PB/DT PASS BOX/DUNK TANK

AUT AUTOCLAVE

GC GARMENT CABINET

PROJECT
SOLID CULTURE LABORATORY (BSL3) AT NIRT, CHENNAI

CLIENT:-
 NIRT CHENNAI

TITLE:-
 LIGHTING LAYOUT

Drawing No.
 NIRT/DST/BSL3/01

Scale	Date	REV.
	27.12.2018	R0

LEGEND:-

L-1	(600X600) 40W LED LIGHT
L-2	(600X300) 40W LED LIGHT (IP55)